



POWER DDC SECTION

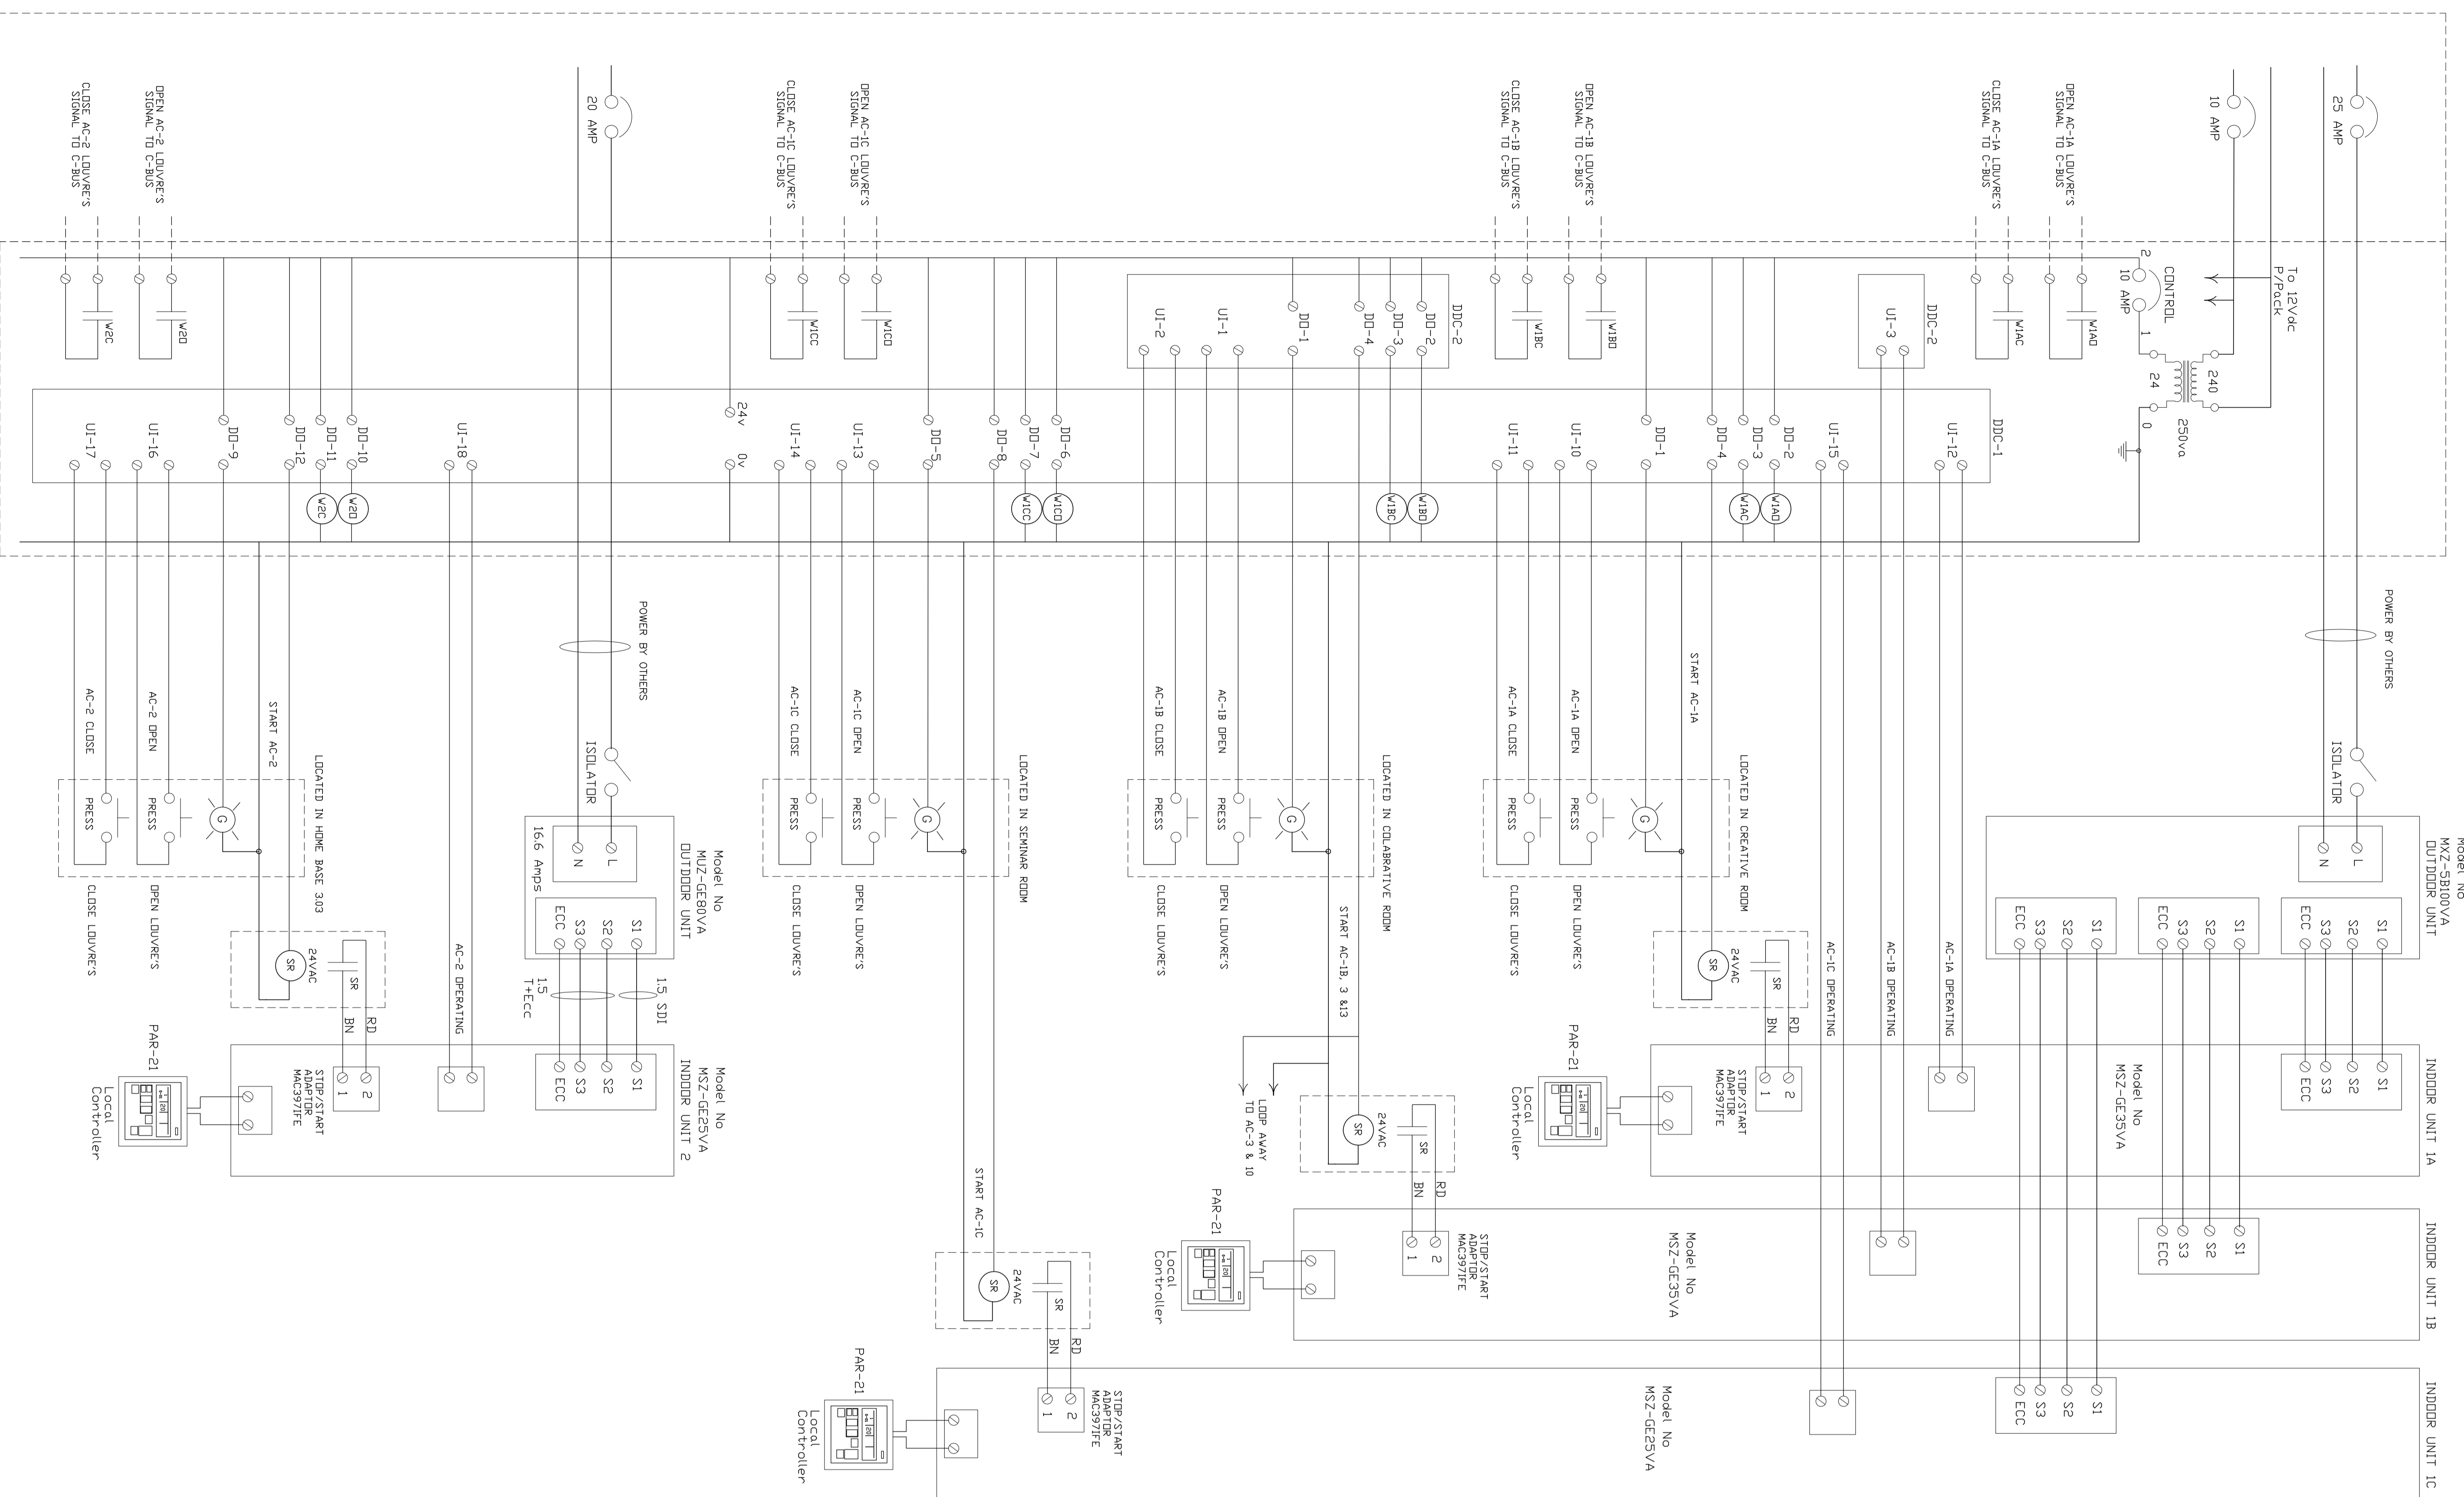

POWER DDC SECTION

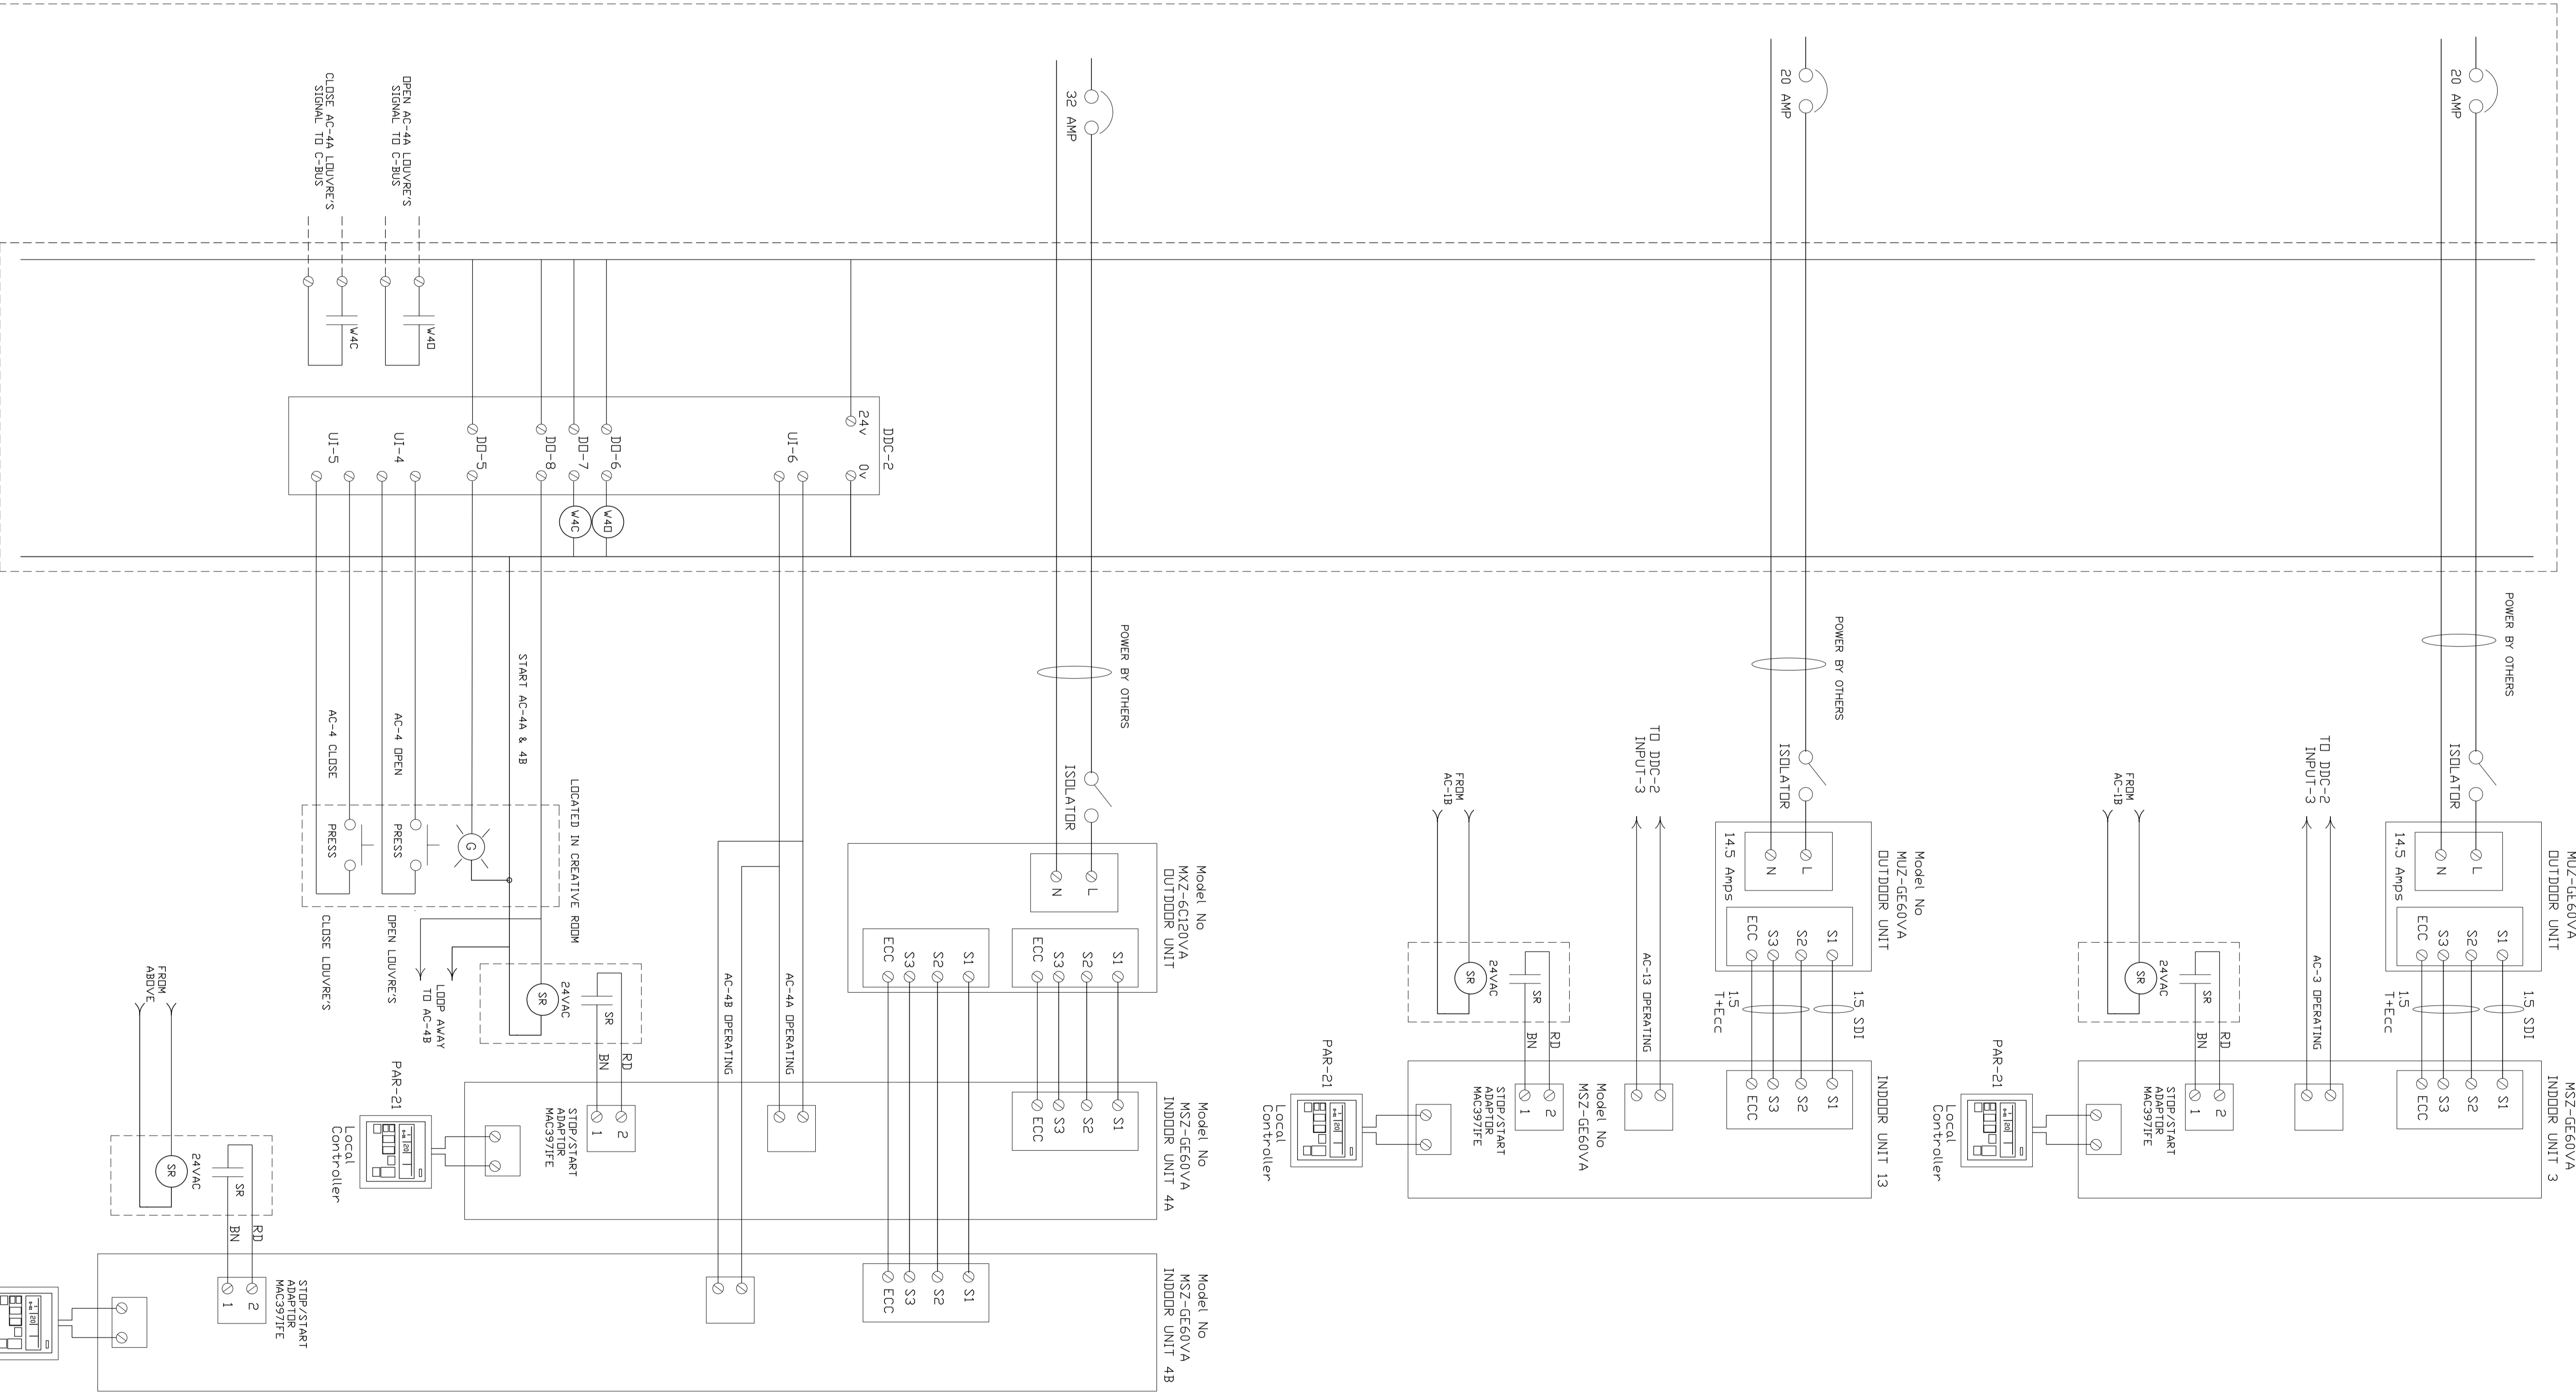

No	ISSUE	BY	DATE	No	ISSUE	BY	DATE

No	BY	DATE

DATE	30th of June 2011	DESIGNED	RR
SCALE	N/A	CHECKED	
DRAWN	RR	No. IN SET	1 OF 4

CONTROL & DESIGN PTY
 LTD
 52 TAYLORS LANE STRATHFIELDSAYE
 TEL (03) 54393495 FAX (03) 54393126
 A.C.N. 0866988779

PROJECT
 FAOLEHAHAWK NORTH PRIMARY SCHOOL
 MECHANICAL SERVICES

TITLE
 ELECTRICAL SCHEMATICS
 FOR THE
 AIRCONDITIONING CONTROL

PROJECT No. DRAWING No. REVISION
 S-6078 E1 1
 CAD FILE No. FAOLEHAHAWK/ELECTRICAL SCHEMATIC